

HĀWERA MEMORIAL THEATRE

HOUSE LIGHTING PLAN

- GrandMA 3 PATCH -

- 47 - CYCLORAMA
- 45 - LEG 5
- 43 -
- 41 - LX 5
- 39 - BORDER 5
- 37 - LX 4
- 35 - LEG 4
- 34 - SMOTHER
- 32 -
- 30 -
- 28 - DRAW TABS
- 26 - LX 3
- 24 - BORDER 3
- 22 -
- 20 - LEG 3
- 18 - BORDER 2
- 16 -
- 15 - LX 2
- 13 - LEG 2
- 11 - BORDER 1
- 9 -
- 7 -
- 5 - LEG 1
- 3 - LX 1
- 1 -
- 0.5 - FIXED PIPE
- 0 - HOUSE CURTAIN

	Fresnel 1200W	27
	PC 1200W	12
	Barndoor	38
	Pacific 23-50	14
	Pacific 45-75	3
	Harmony F	2
	Silhouette 30	2
	500W Flood As B.S. Workers	2
	Lui Cyc	5
	Showpro RGBAL LED Fresnel w/ Zoom (10 Channel mode)	20
	1200W Zoomspot Setup as Followspot	2


Key

Use	xx
Fitting	
DMX Address	xx
Circuit	





Drawn: A Midgley, May 2024

DO NOT SCALE

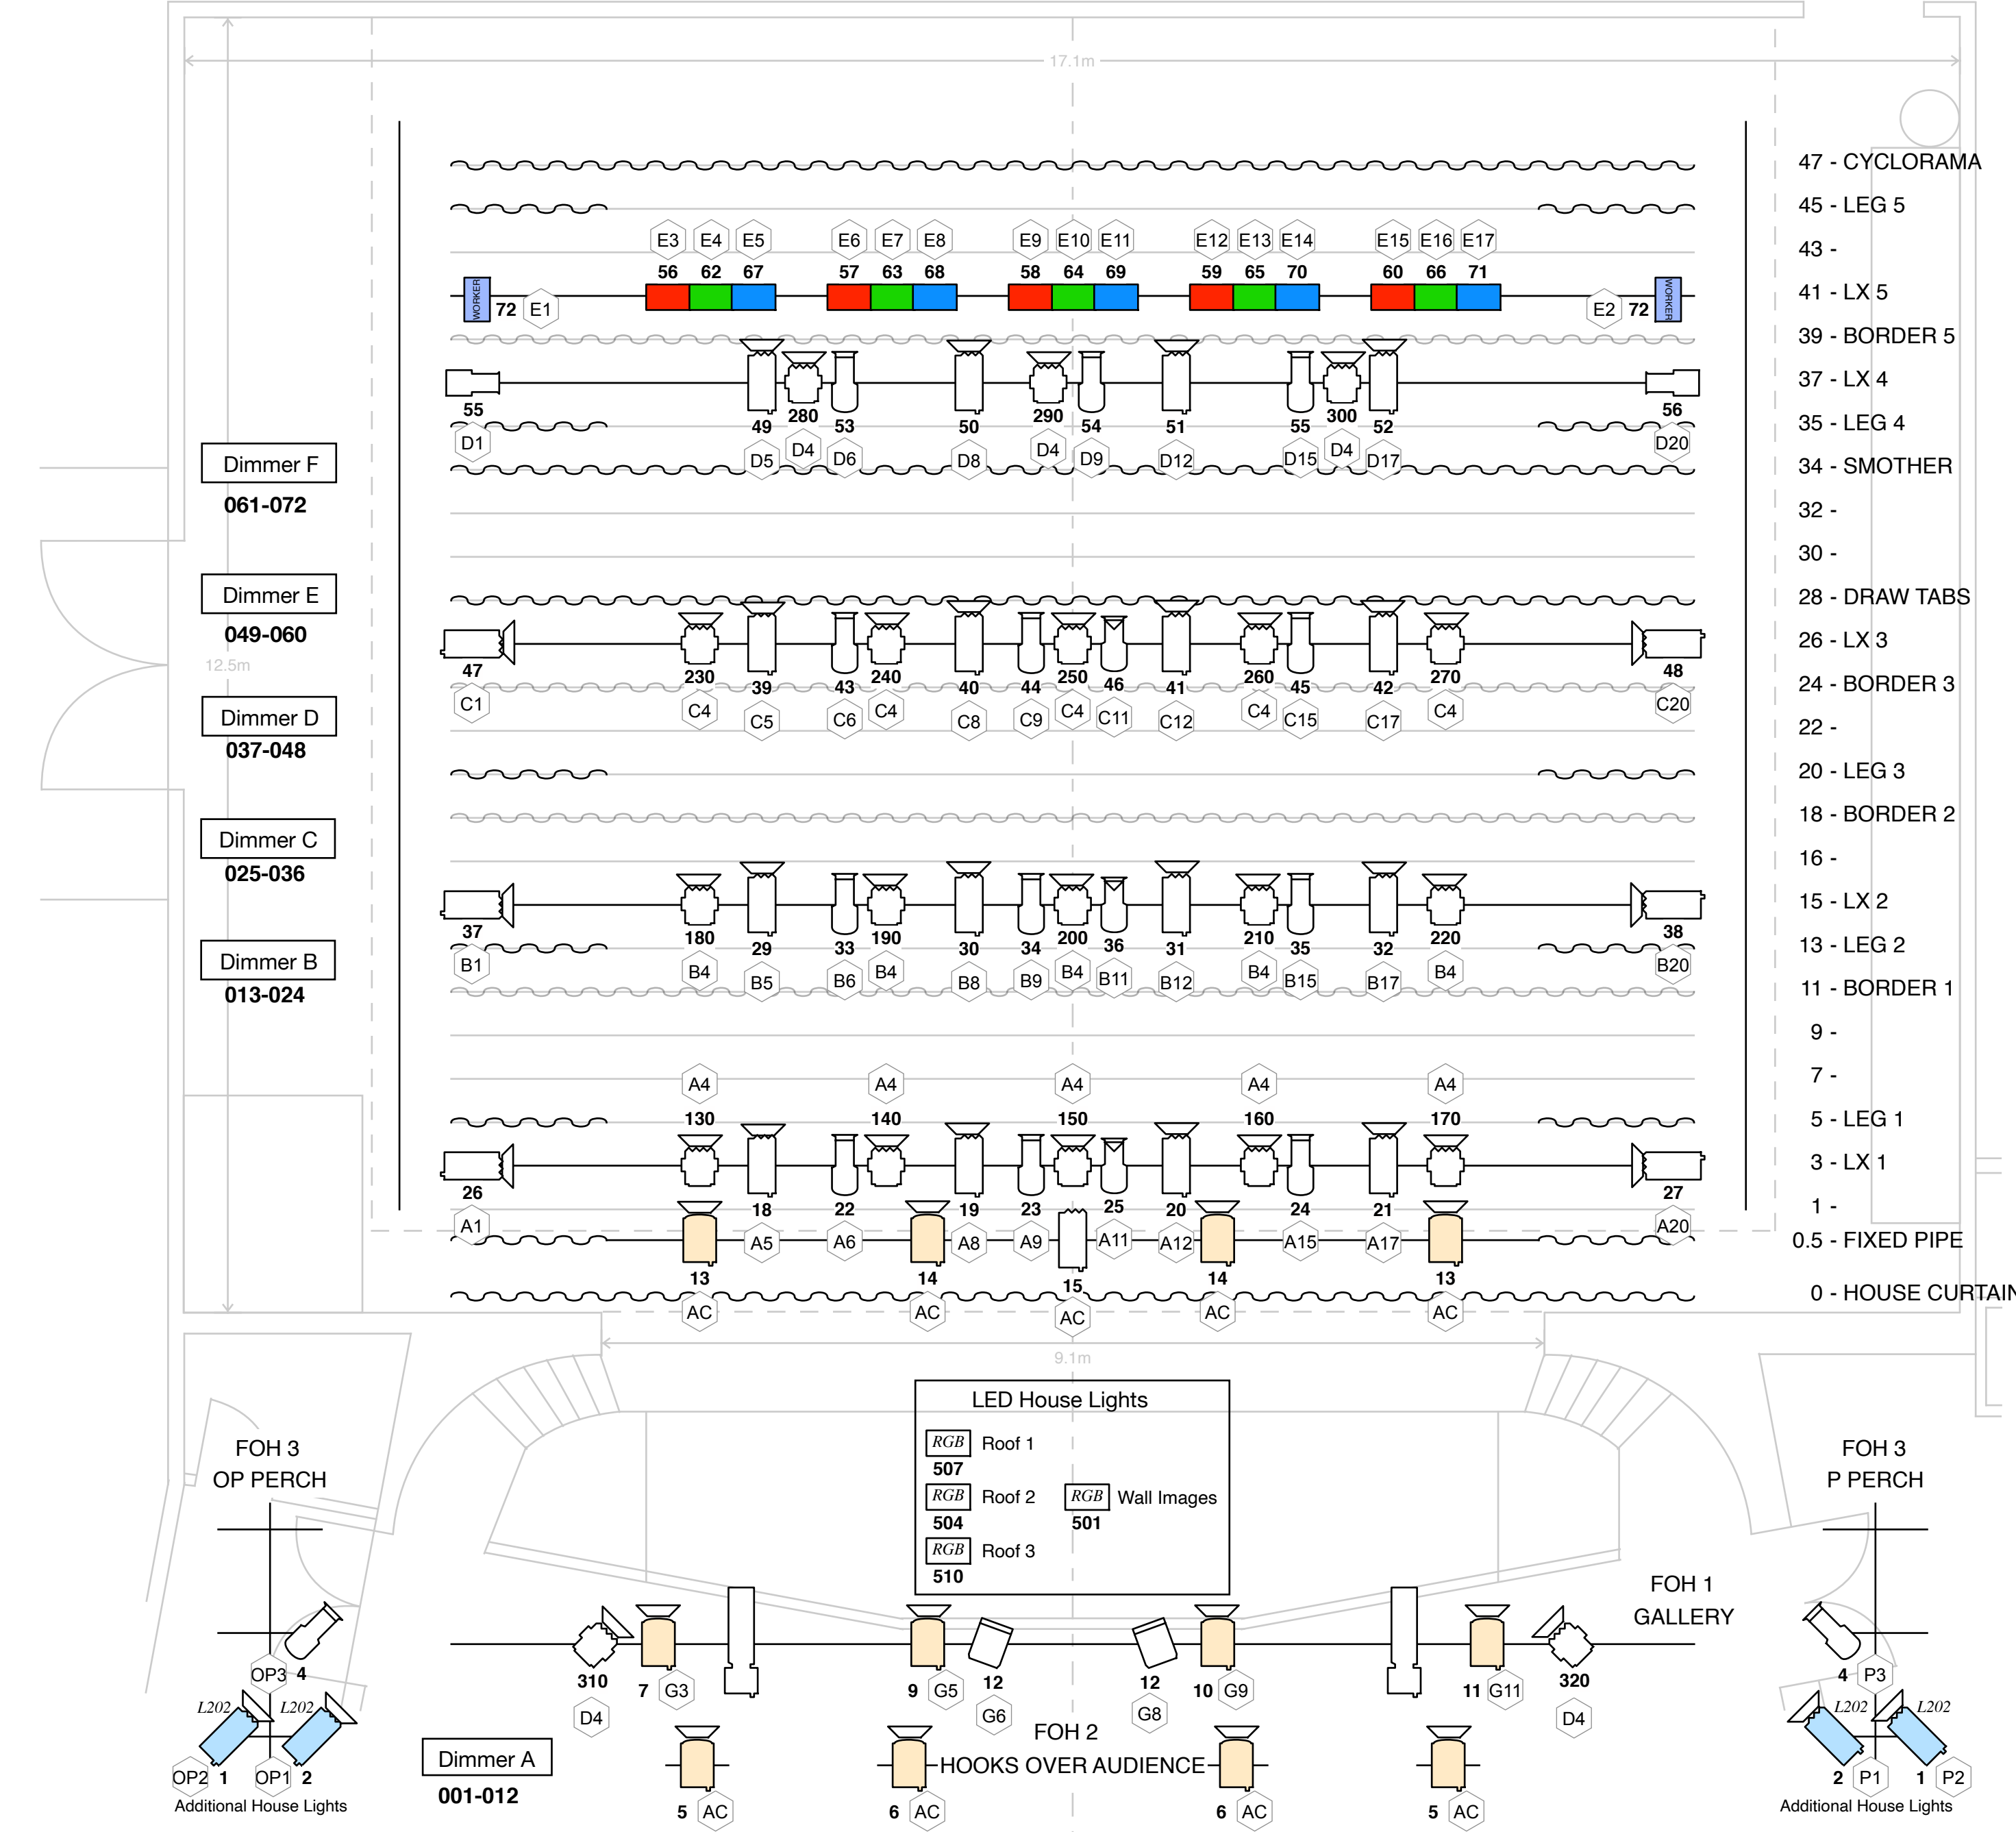

- Dimmer F
061-072
- Dimmer E
049-060
- Dimmer D
037-048
- Dimmer C
025-036
- Dimmer B
013-024

- Dimmer A
001-012

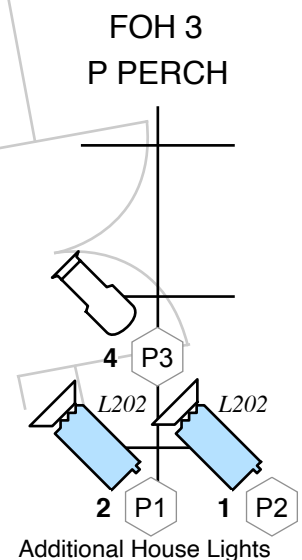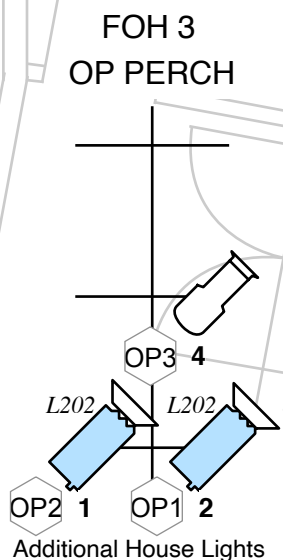

LED House Lights

RGB	Roof 1	507
RGB	Roof 2	504
RGB	Roof 3	510
RGB	Wall Images	501